


These architectural drawings have been prepared for the use of the contractor and are not to be used for any other related engineering design and specifications are the responsibility of the respective engineer. Compliance to these drawings is the responsibility of the contractor. Local building codes should be conformed to. All measurements shall be verified by the contractor performing the respective work.

**PLANEVIEW PARK
PECAN PLANTATION AIRPARK**


AREA CALCULATIONS

ENTERTAIN	3365 S.F.
OUTDOOR	1635 S.F.
TOTAL SLAB	5000 S.F.


	SHEET NO.
	A-1
DATE: 09/29/15	

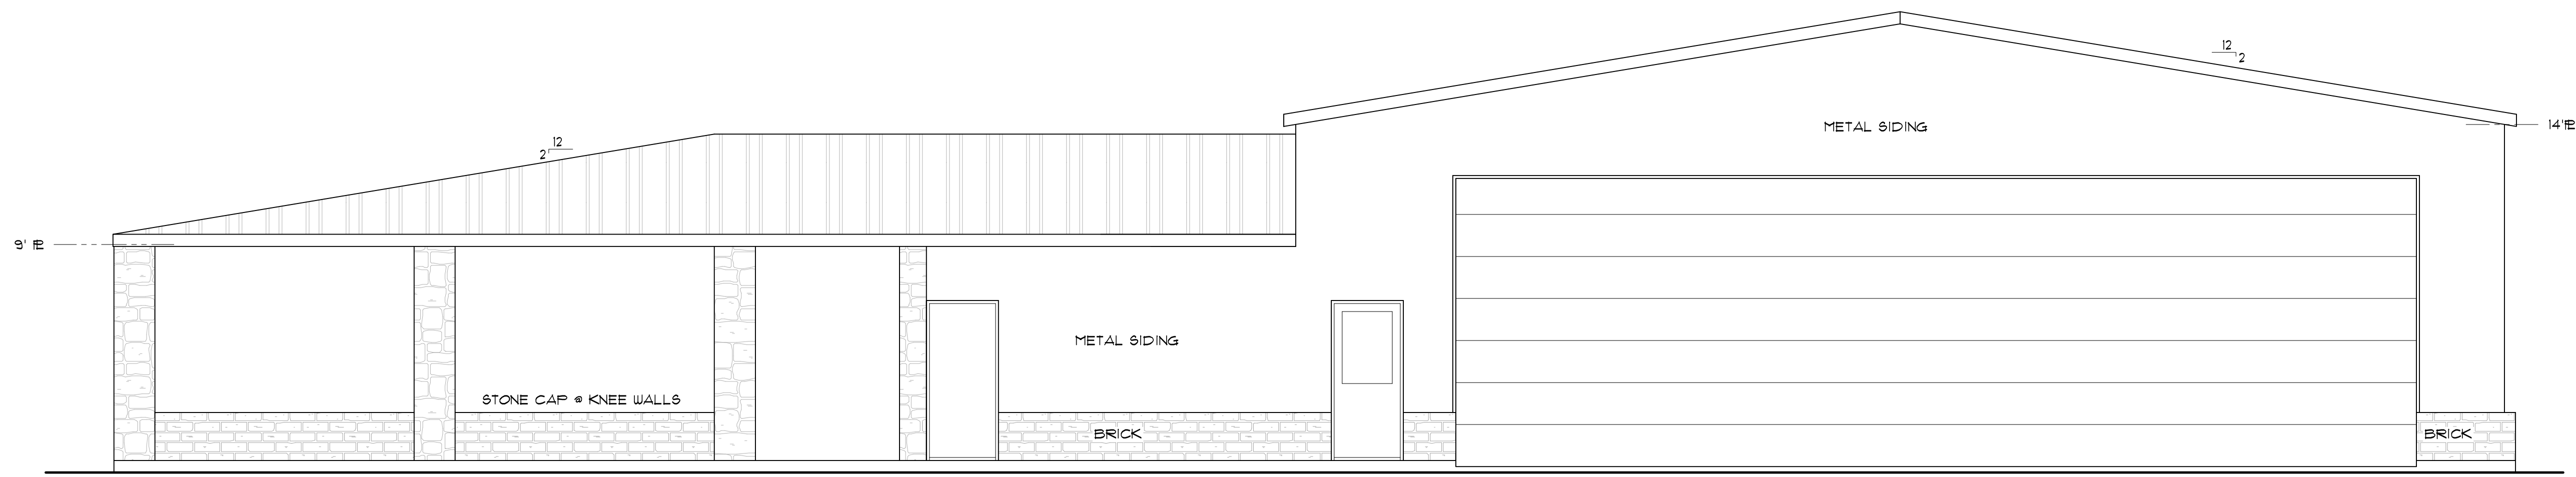


BACK ELEVATION
SCALE: 1/4" = 1'-0"

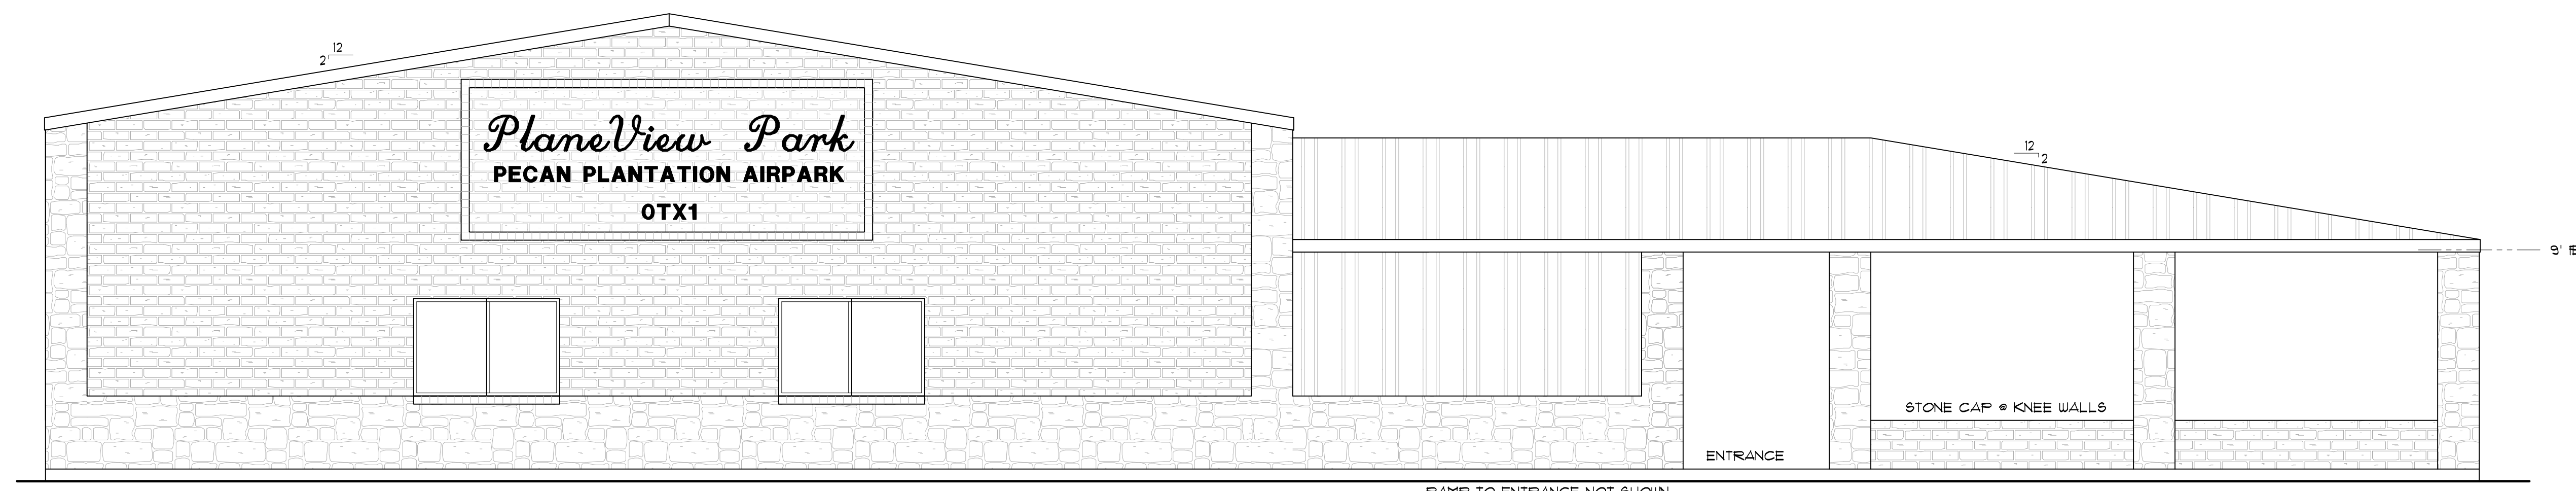


FRONT ELEVATION
SCALE: 1/4" = 1'-0"

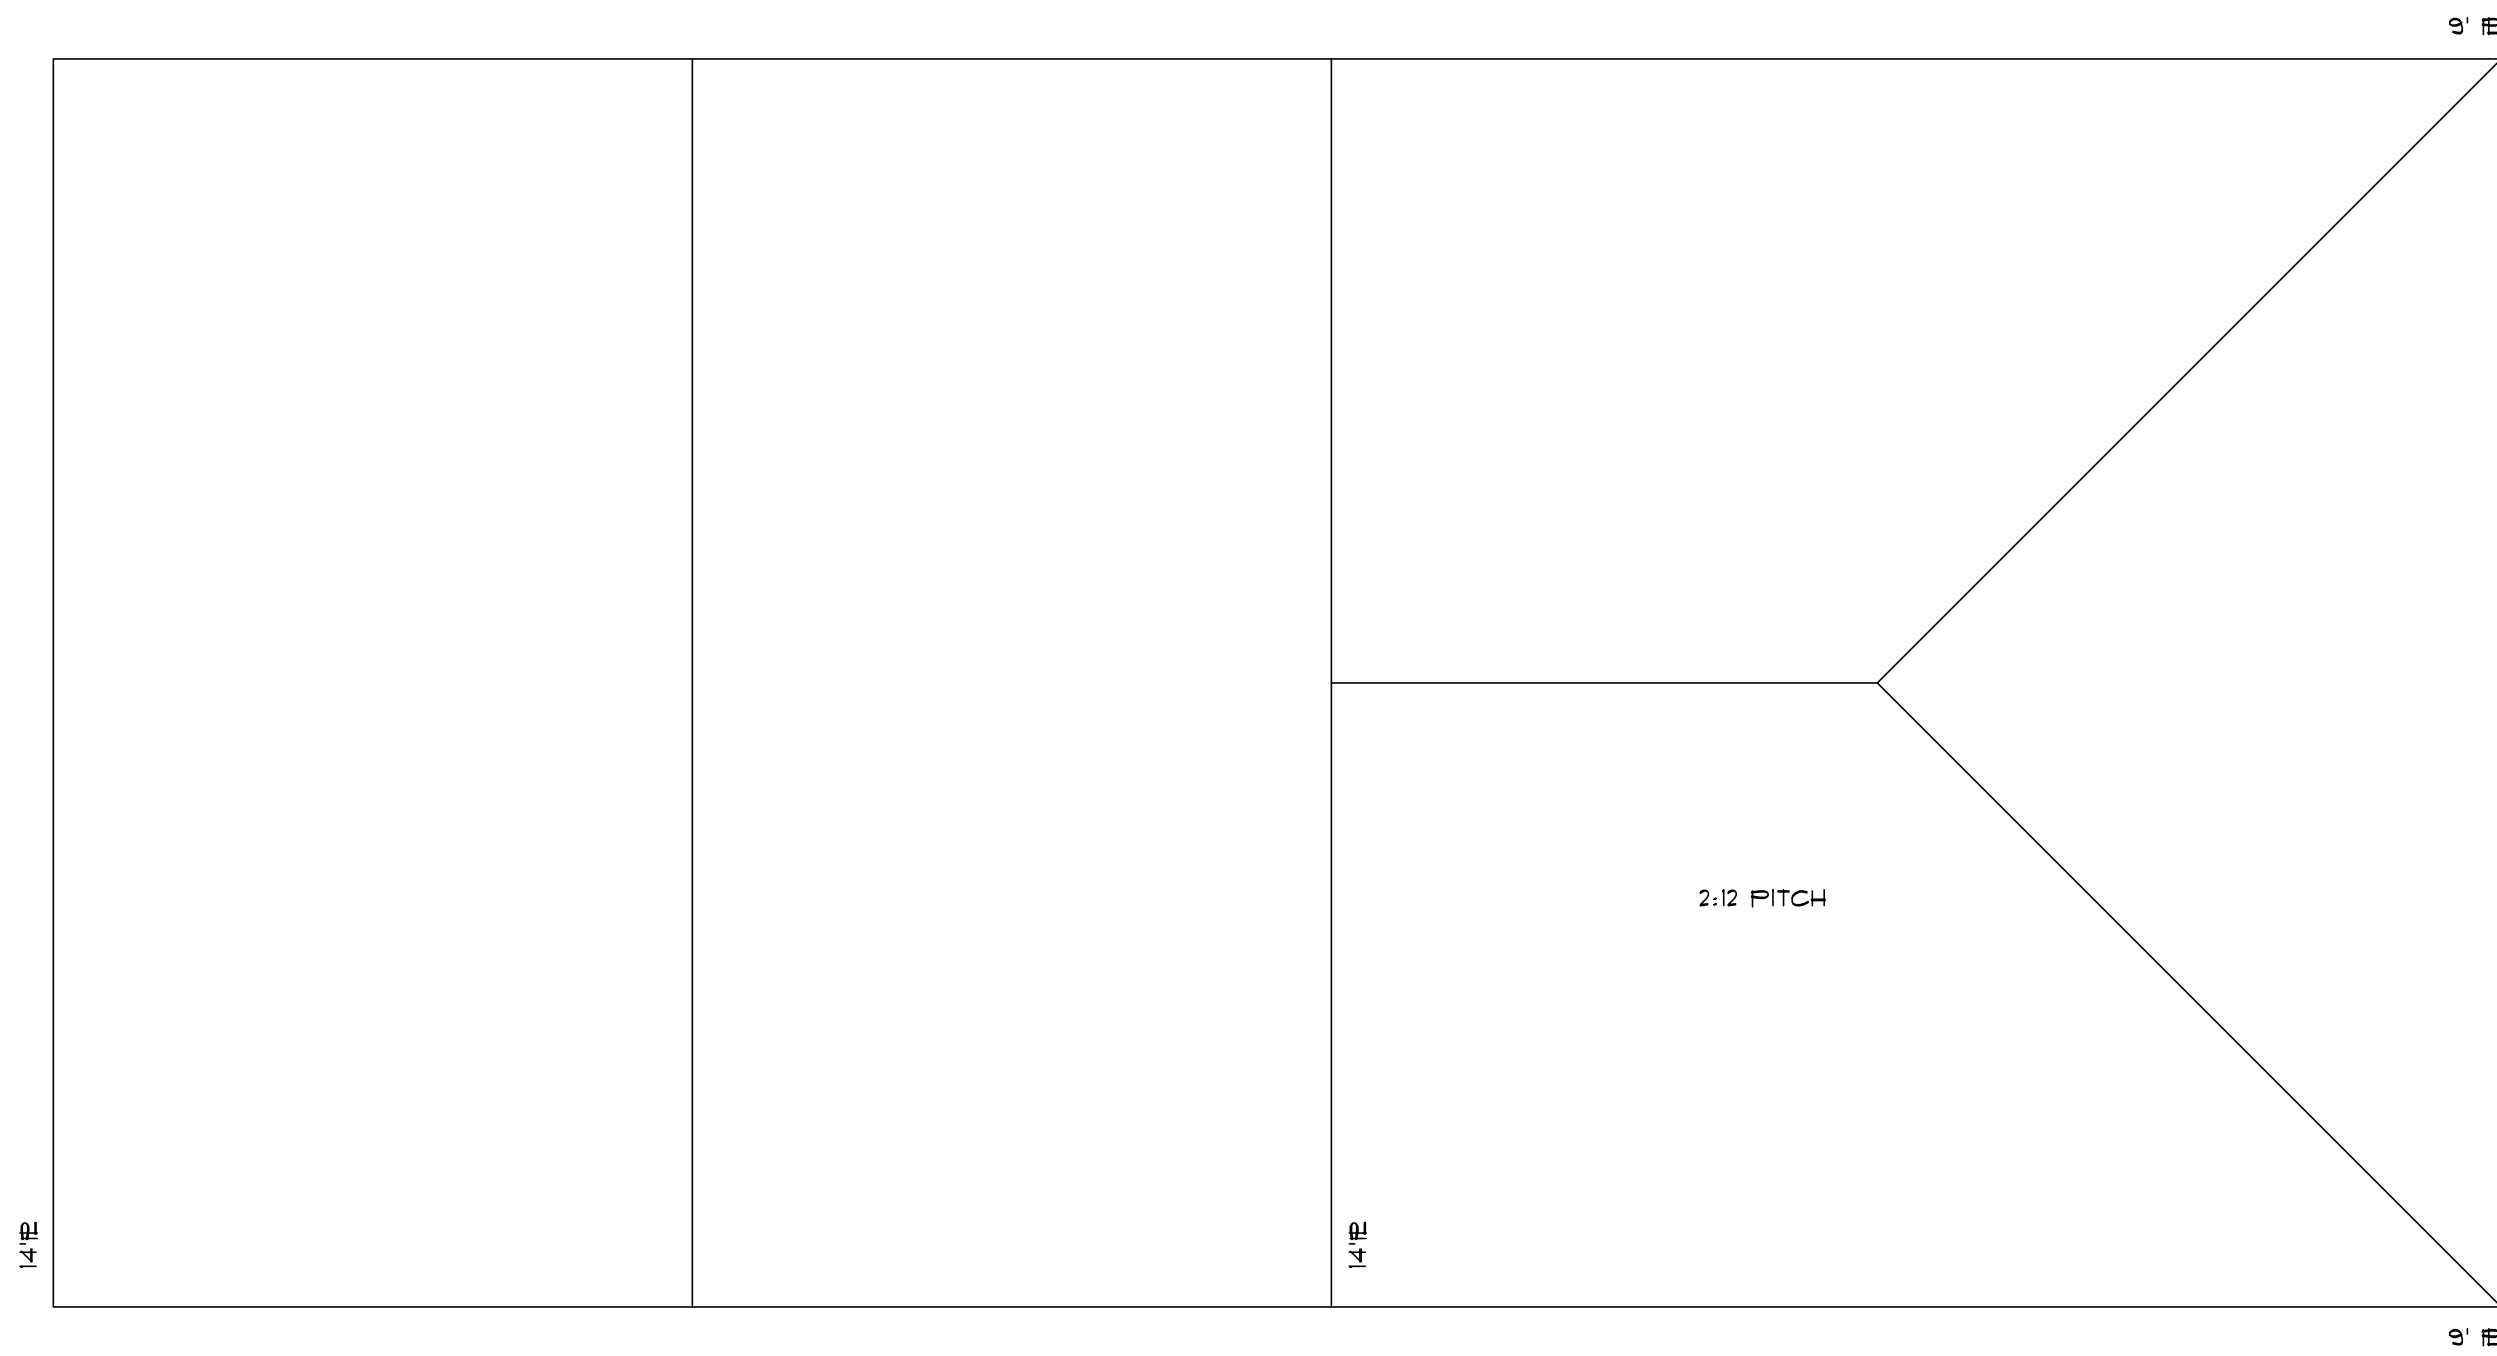

ROOF PLAN
SCALE: 1/8" = 1'-0"

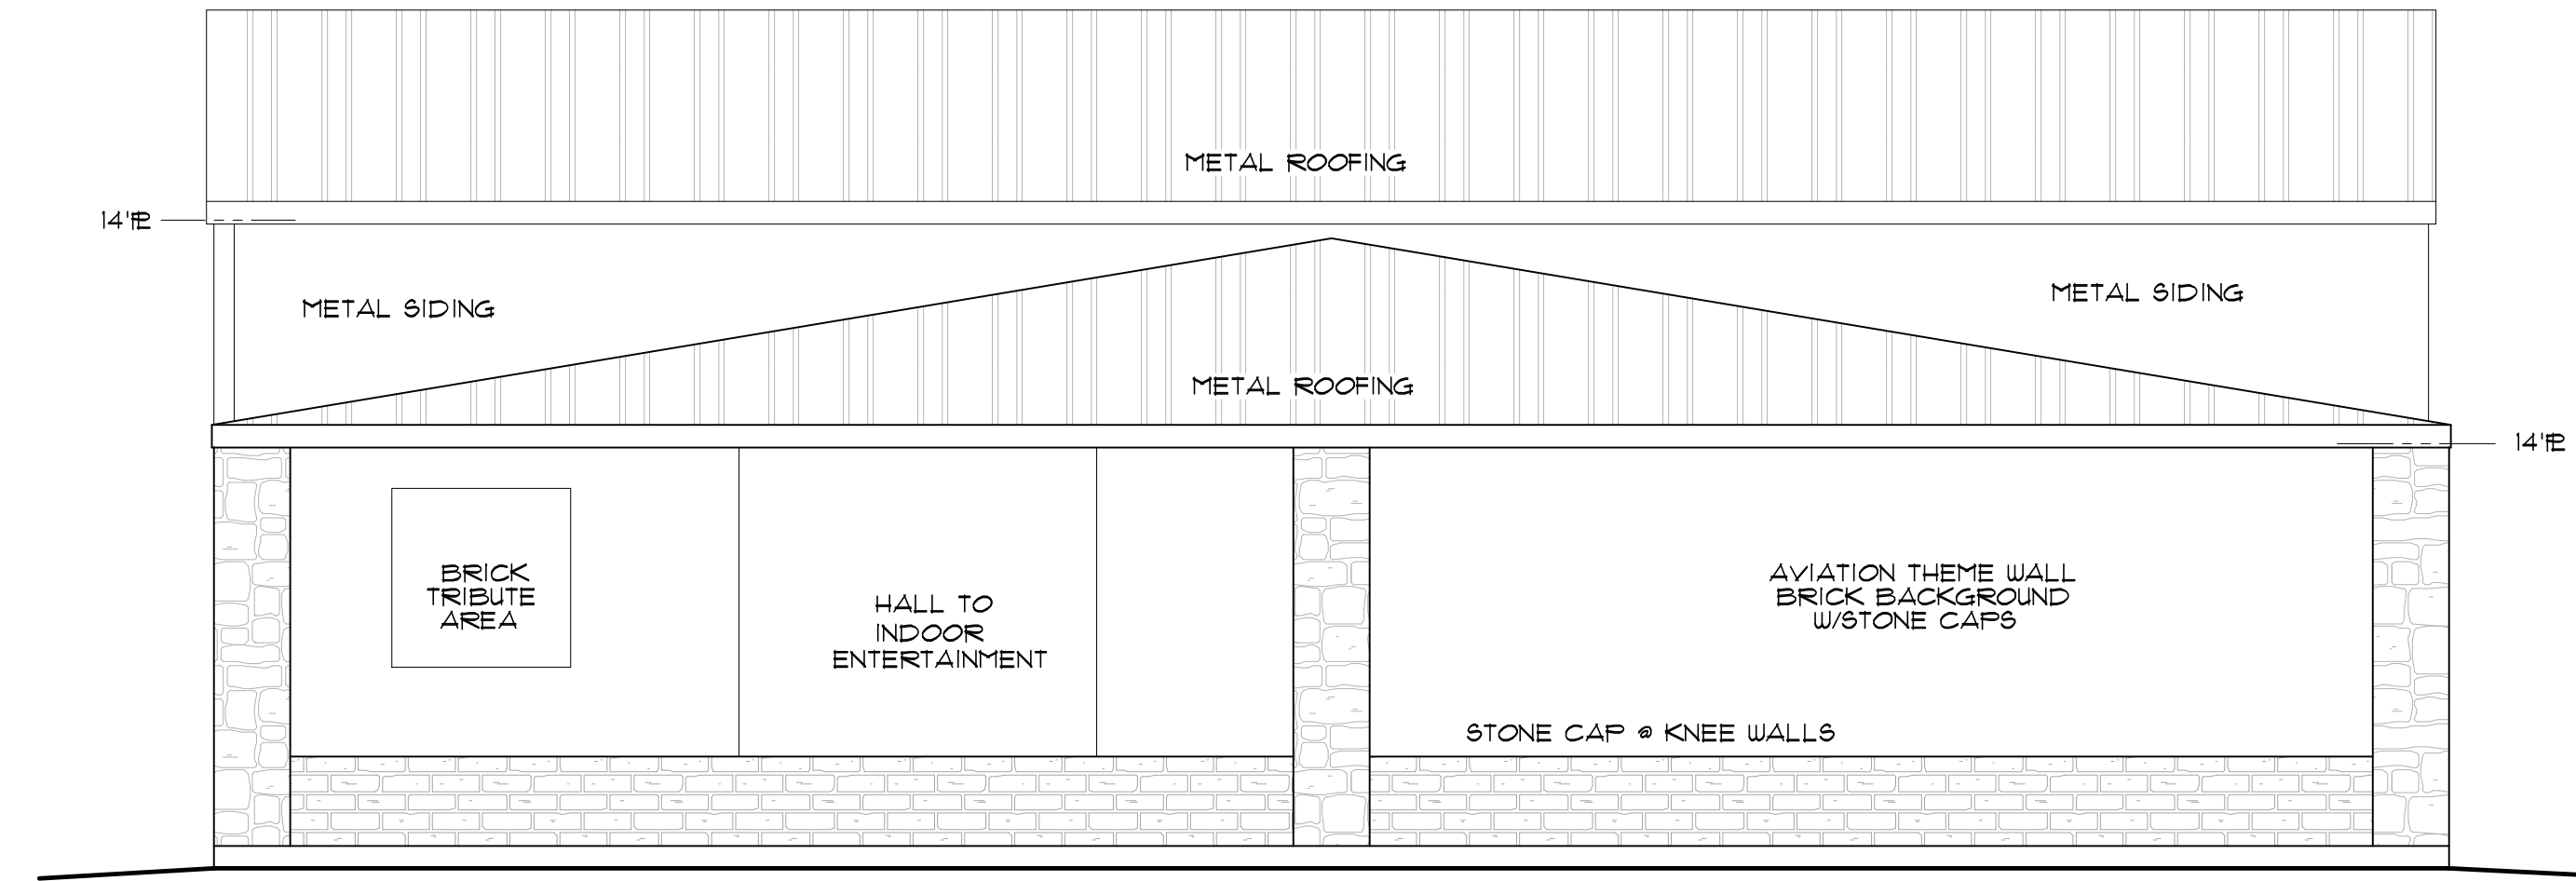

RIGHT ELEVATION
SCALE: 1/4" = 1'-0"

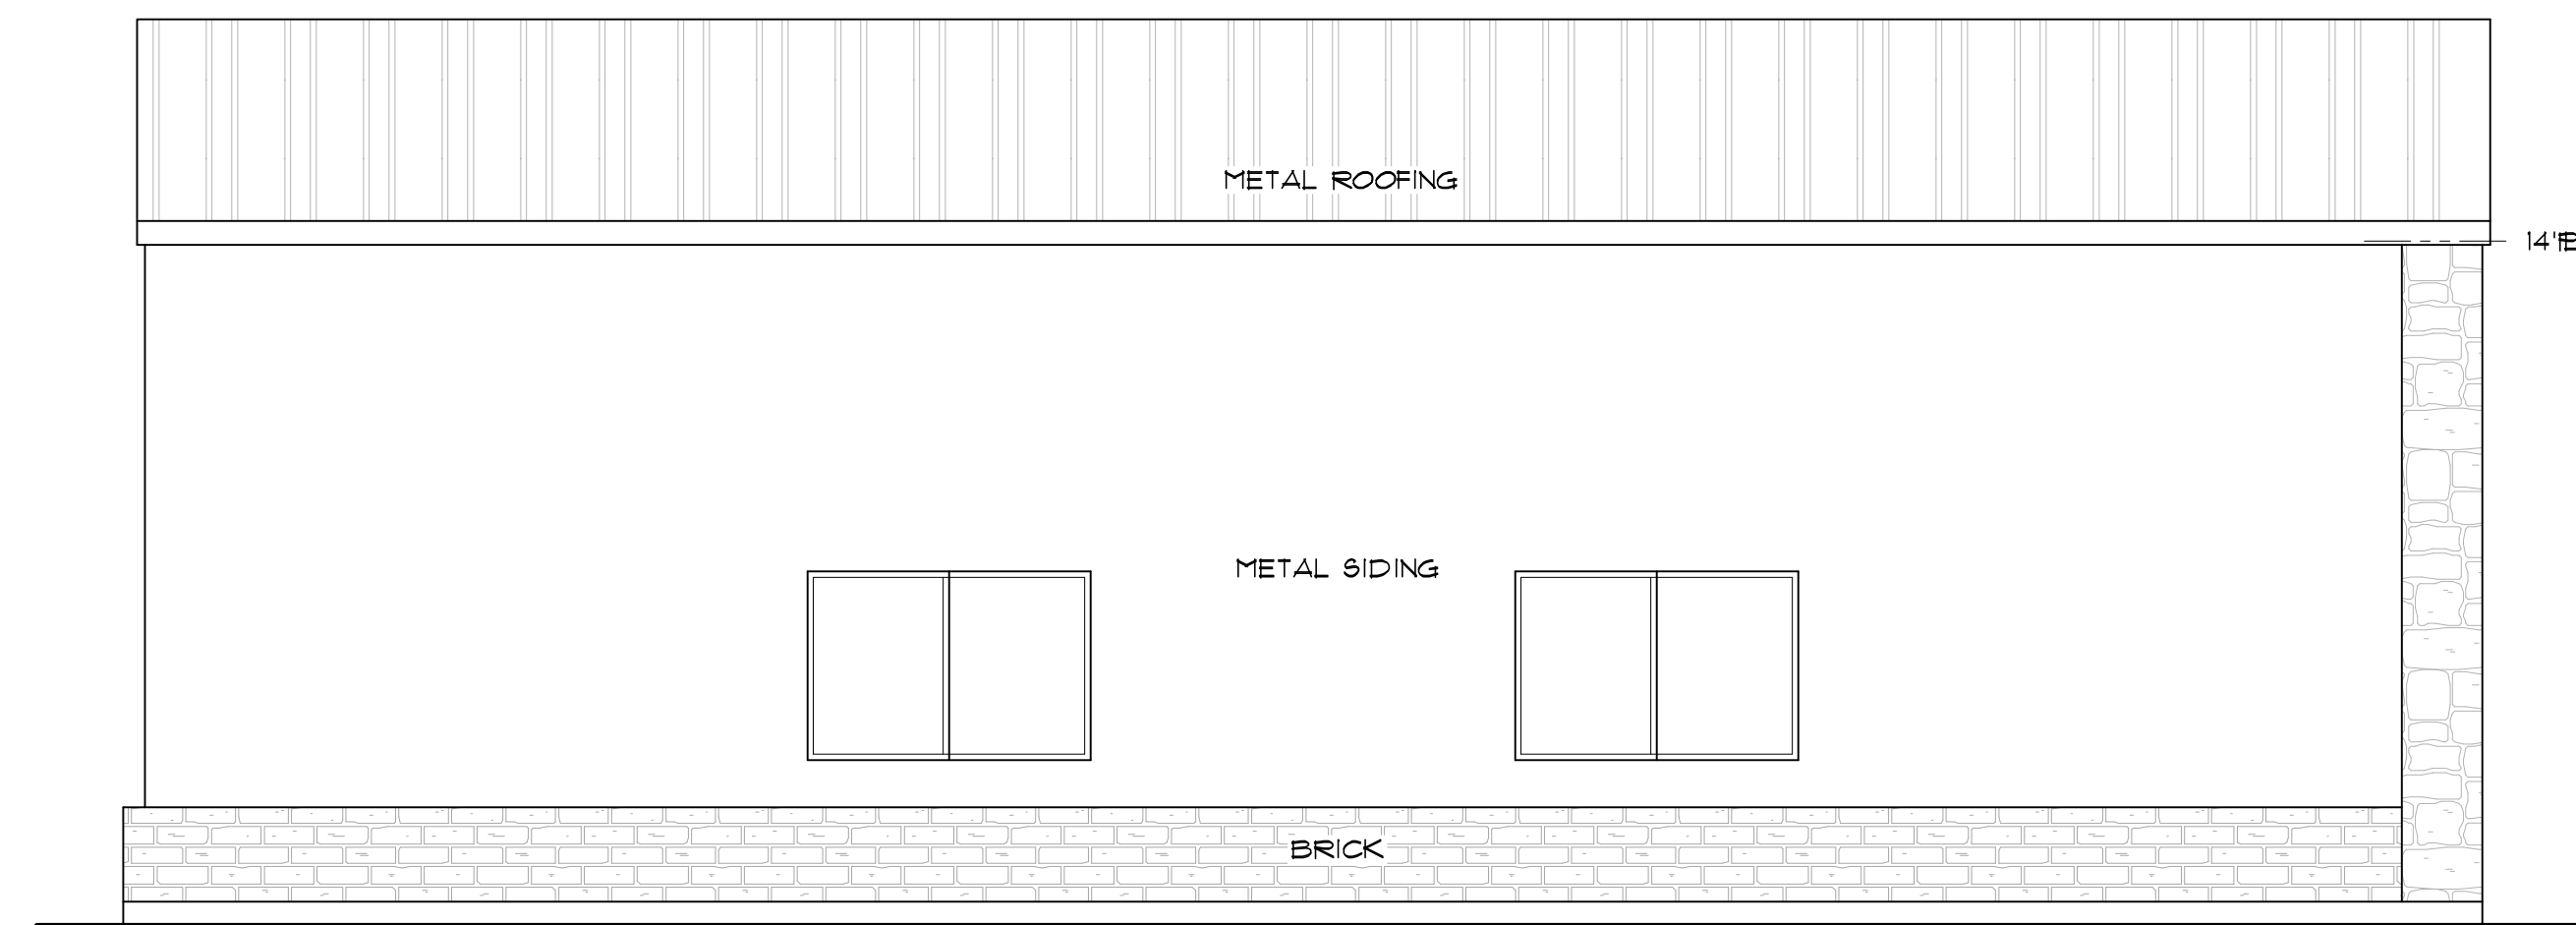

LEFT ELEVATION
SCALE: 1/4" = 1'-0"


These architectural drawings have been prepared for the use of the contractor and are not to be used for any other design or construction without the written consent of the architect. The architect is not responsible for any errors or omissions in these drawings or for any consequences arising therefrom. The contractor shall be responsible for obtaining all necessary permits and for complying with all applicable building codes and regulations. All measurements shall be verified by the contractor performing the respective work.

**PLANEVIEW PARK
PECAN PLANTATION AIRPARK**

AREA CALCULATIONS

ENTERTAIN	3365 S.F.
OUTDOOR	1635 S.F.
TOTAL SLAB	5000 S.F.

DATE: 09/29/15	SHEET NO. A-2
----------------	-------------------------

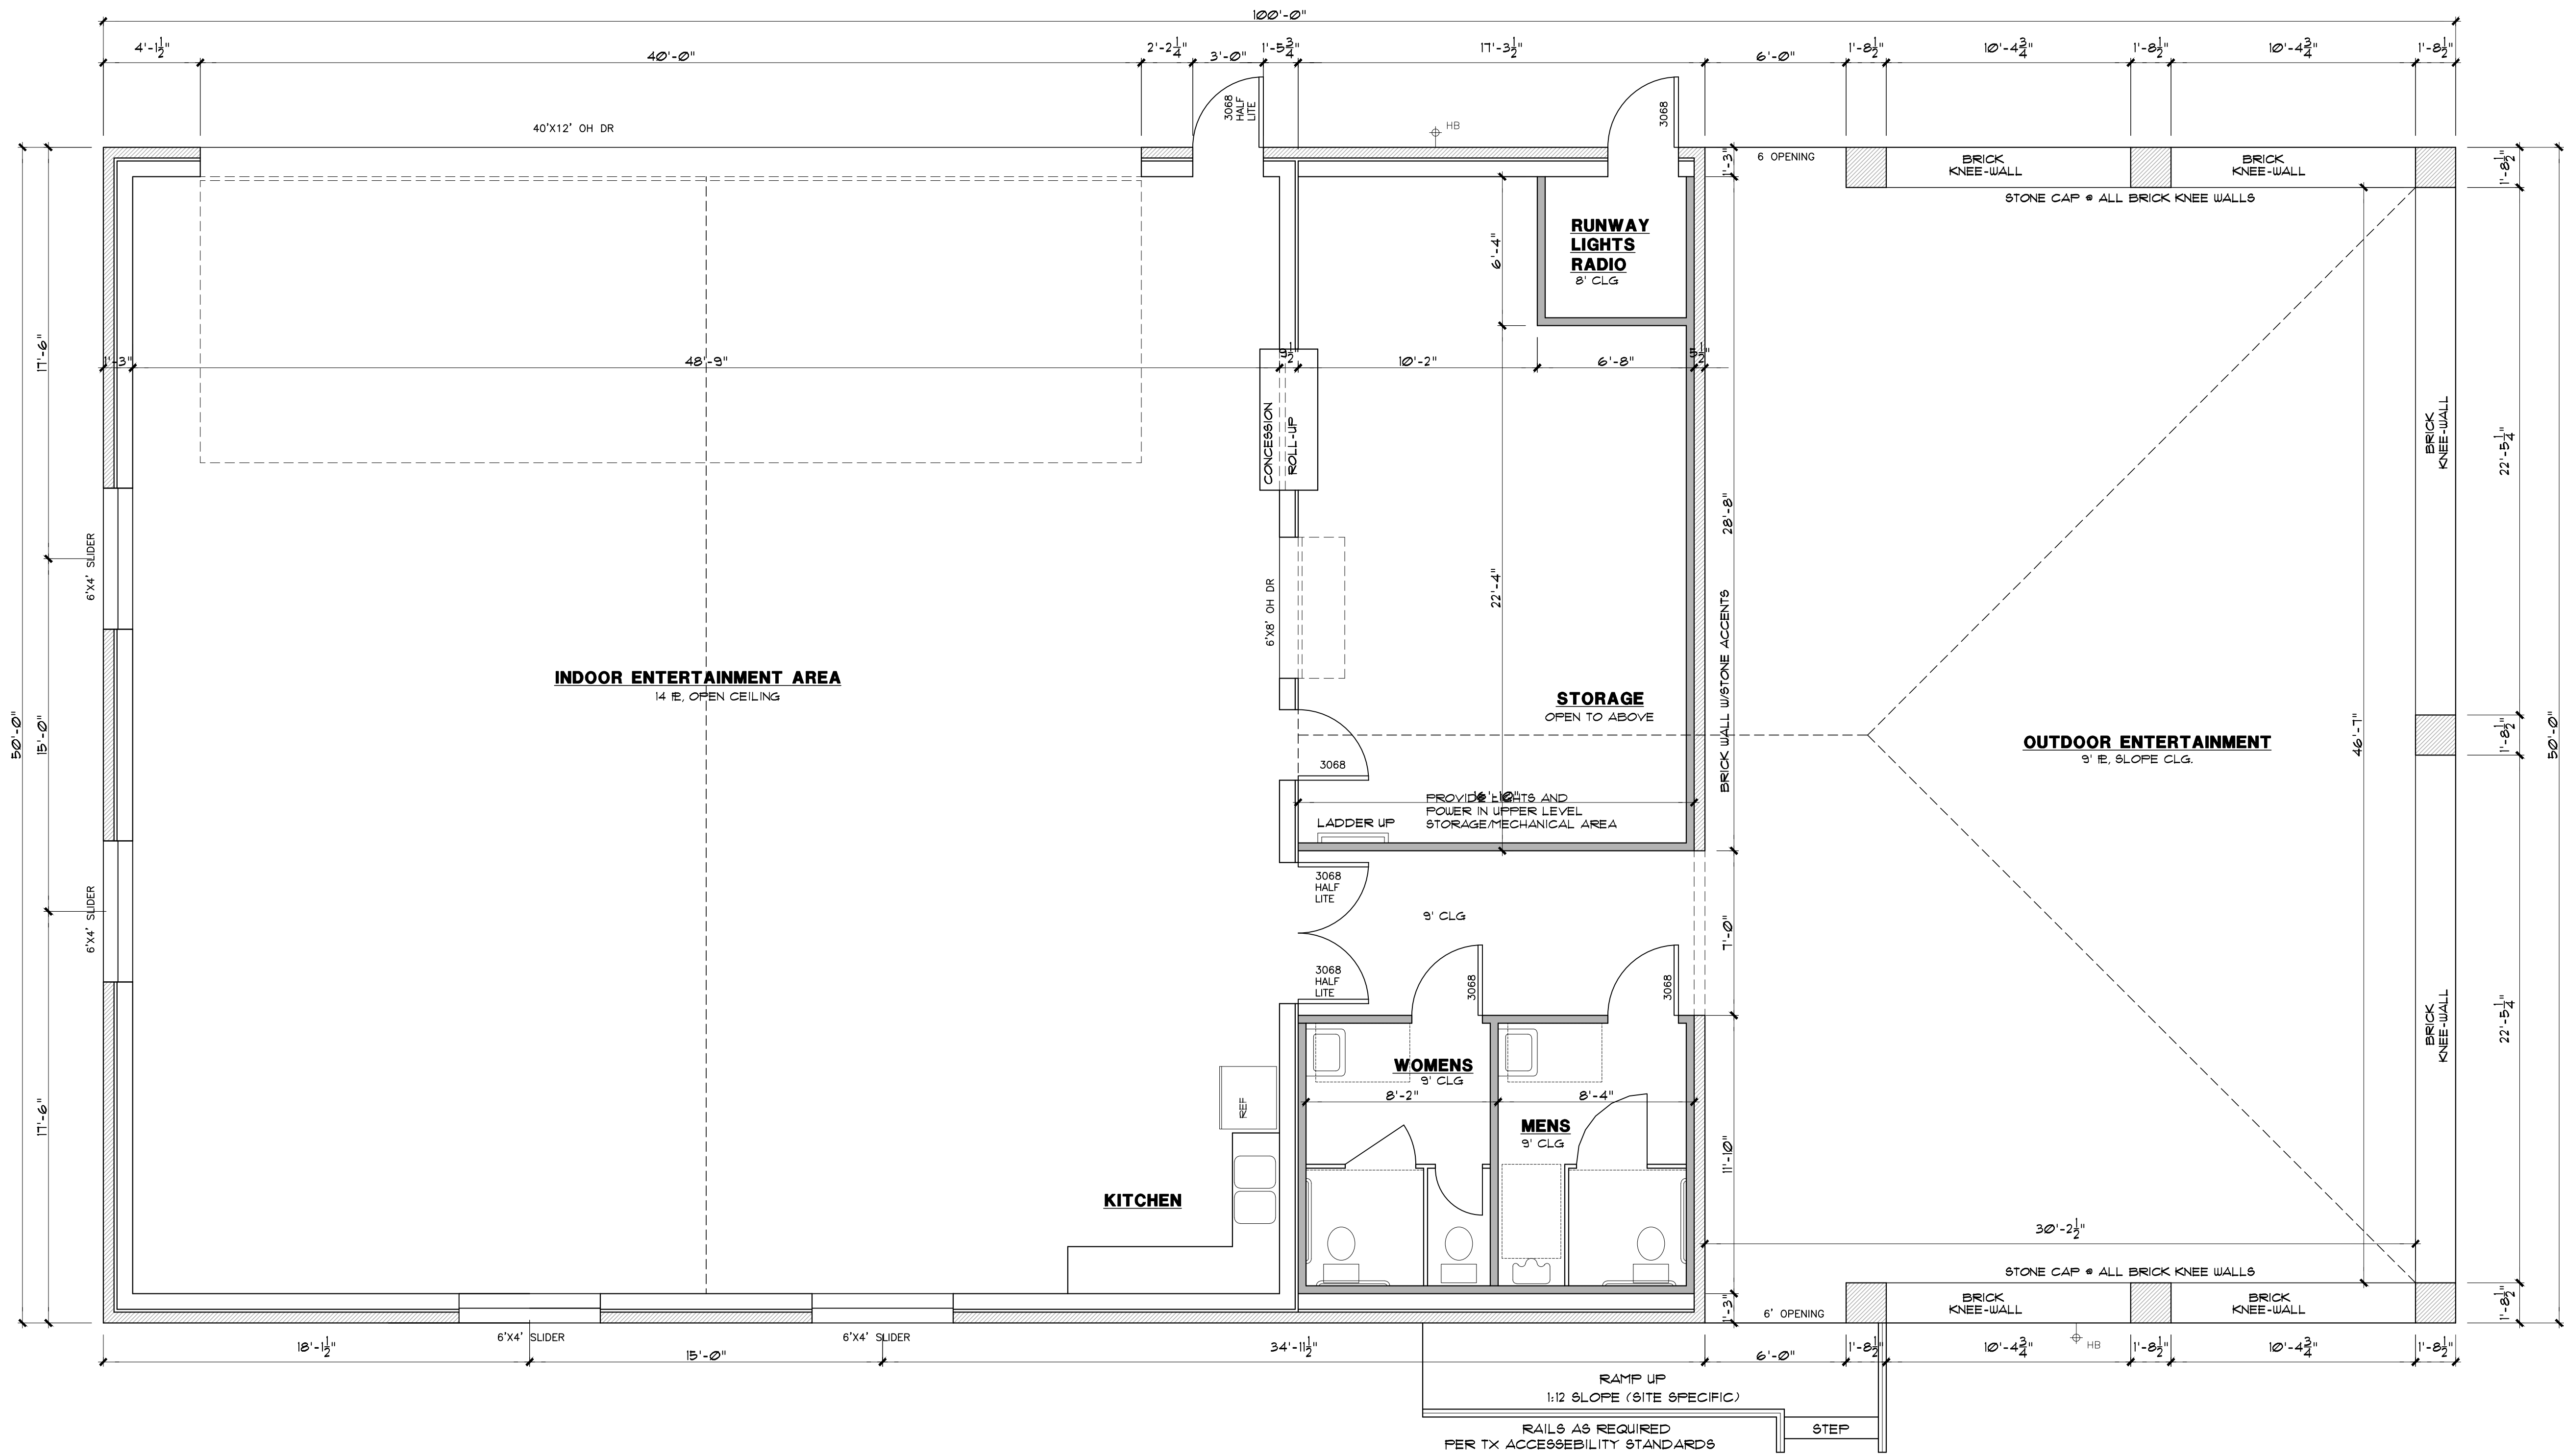

These architectural drawings have been prepared for the use of the owner and are not to be used for any other related engineering design and specifications are the responsibility of the respective engineer. Compliance to these drawings is the responsibility of the contractor. The contractor shall be responsible for obtaining all applicable building codes and verifying that all measurements shall be verified by the contractor performing the respective work.

PLANEVIEW PARK
PECAN PLANTATION AIRPARK

AREA CALCULATIONS

ENTERTAIN	3365 S.F.
OUTDOOR	1635 S.F.
TOTAL SLAB	5000 S.F.

	SHEET NO.
	A-3
DATE: 09/29/15	

These architectural drawings have been prepared for the use of the contractor and are not to be used for any other design or construction. The contractor is responsible for all other related engineering design and specifications are the responsibility of the respective engineer. Compliance to these drawings is the responsibility of the contractor. The contractor shall be responsible for all building codes shall be verified by the contractor performing the respective work.


**PLANEVIEW PARK
 PECAN PLANTATION AIRPARK**

AREA CALCULATIONS

ENTERTAIN	3365 S.F.
OUTDOOR	1635 S.F.
TOTAL SLAB	5000 S.F.

	SHEET NO.
	E-1
DATE: 09/29/15	

- LEGEND**
- ⊕ DUPLEX ELECT. OUTLET
 - ⊕ QUADPLEX ELECT. OUTLET
 - ⊕ 220 V ELECT. OUTLET
 - ▼ PHONE JACK
 - ⊕ TV OUTLET
 - ⊕ CLG. MOUNTED LIGHT FIXTURE (AS SELECTED BY OWNER)
 - ⊕ FLUORESCENT
 - ⊕ WALL MOUNTED LIGHT FIXTURE
 - ⊕ RECESSED CAN LIGHT
 - ⊕ UNDER CABINET LIGHT
 - ⊕ DIRECTIONAL RECESSED CAN LIGHT
 - ⊕ EXTERIOR FLOOD LIGHT
 - ⊕ SPEAKERS
 - ⊕ HEAT, VENT AND/OR LIGHT
 - ⊕ CEILING FAN W/ LIGHT KIT (FANS TO HAVE SPEED CONTROL MOUNTED ON WALL NEAR SWITCH)
 - ⊕ CEILING FAN (FANS TO HAVE SPEED CONTROL MOUNTED ON WALL NEAR SWITCH)
 - ⊕ SWITCH
 - ⊕ 3-WAY SWITCH
 - ⊕ WEATHER PROTECTED
- VERIFY ELECTRICAL AND LIGHTING INFORMATION WITH OWNER PRIOR TO BEGINNING WORK.

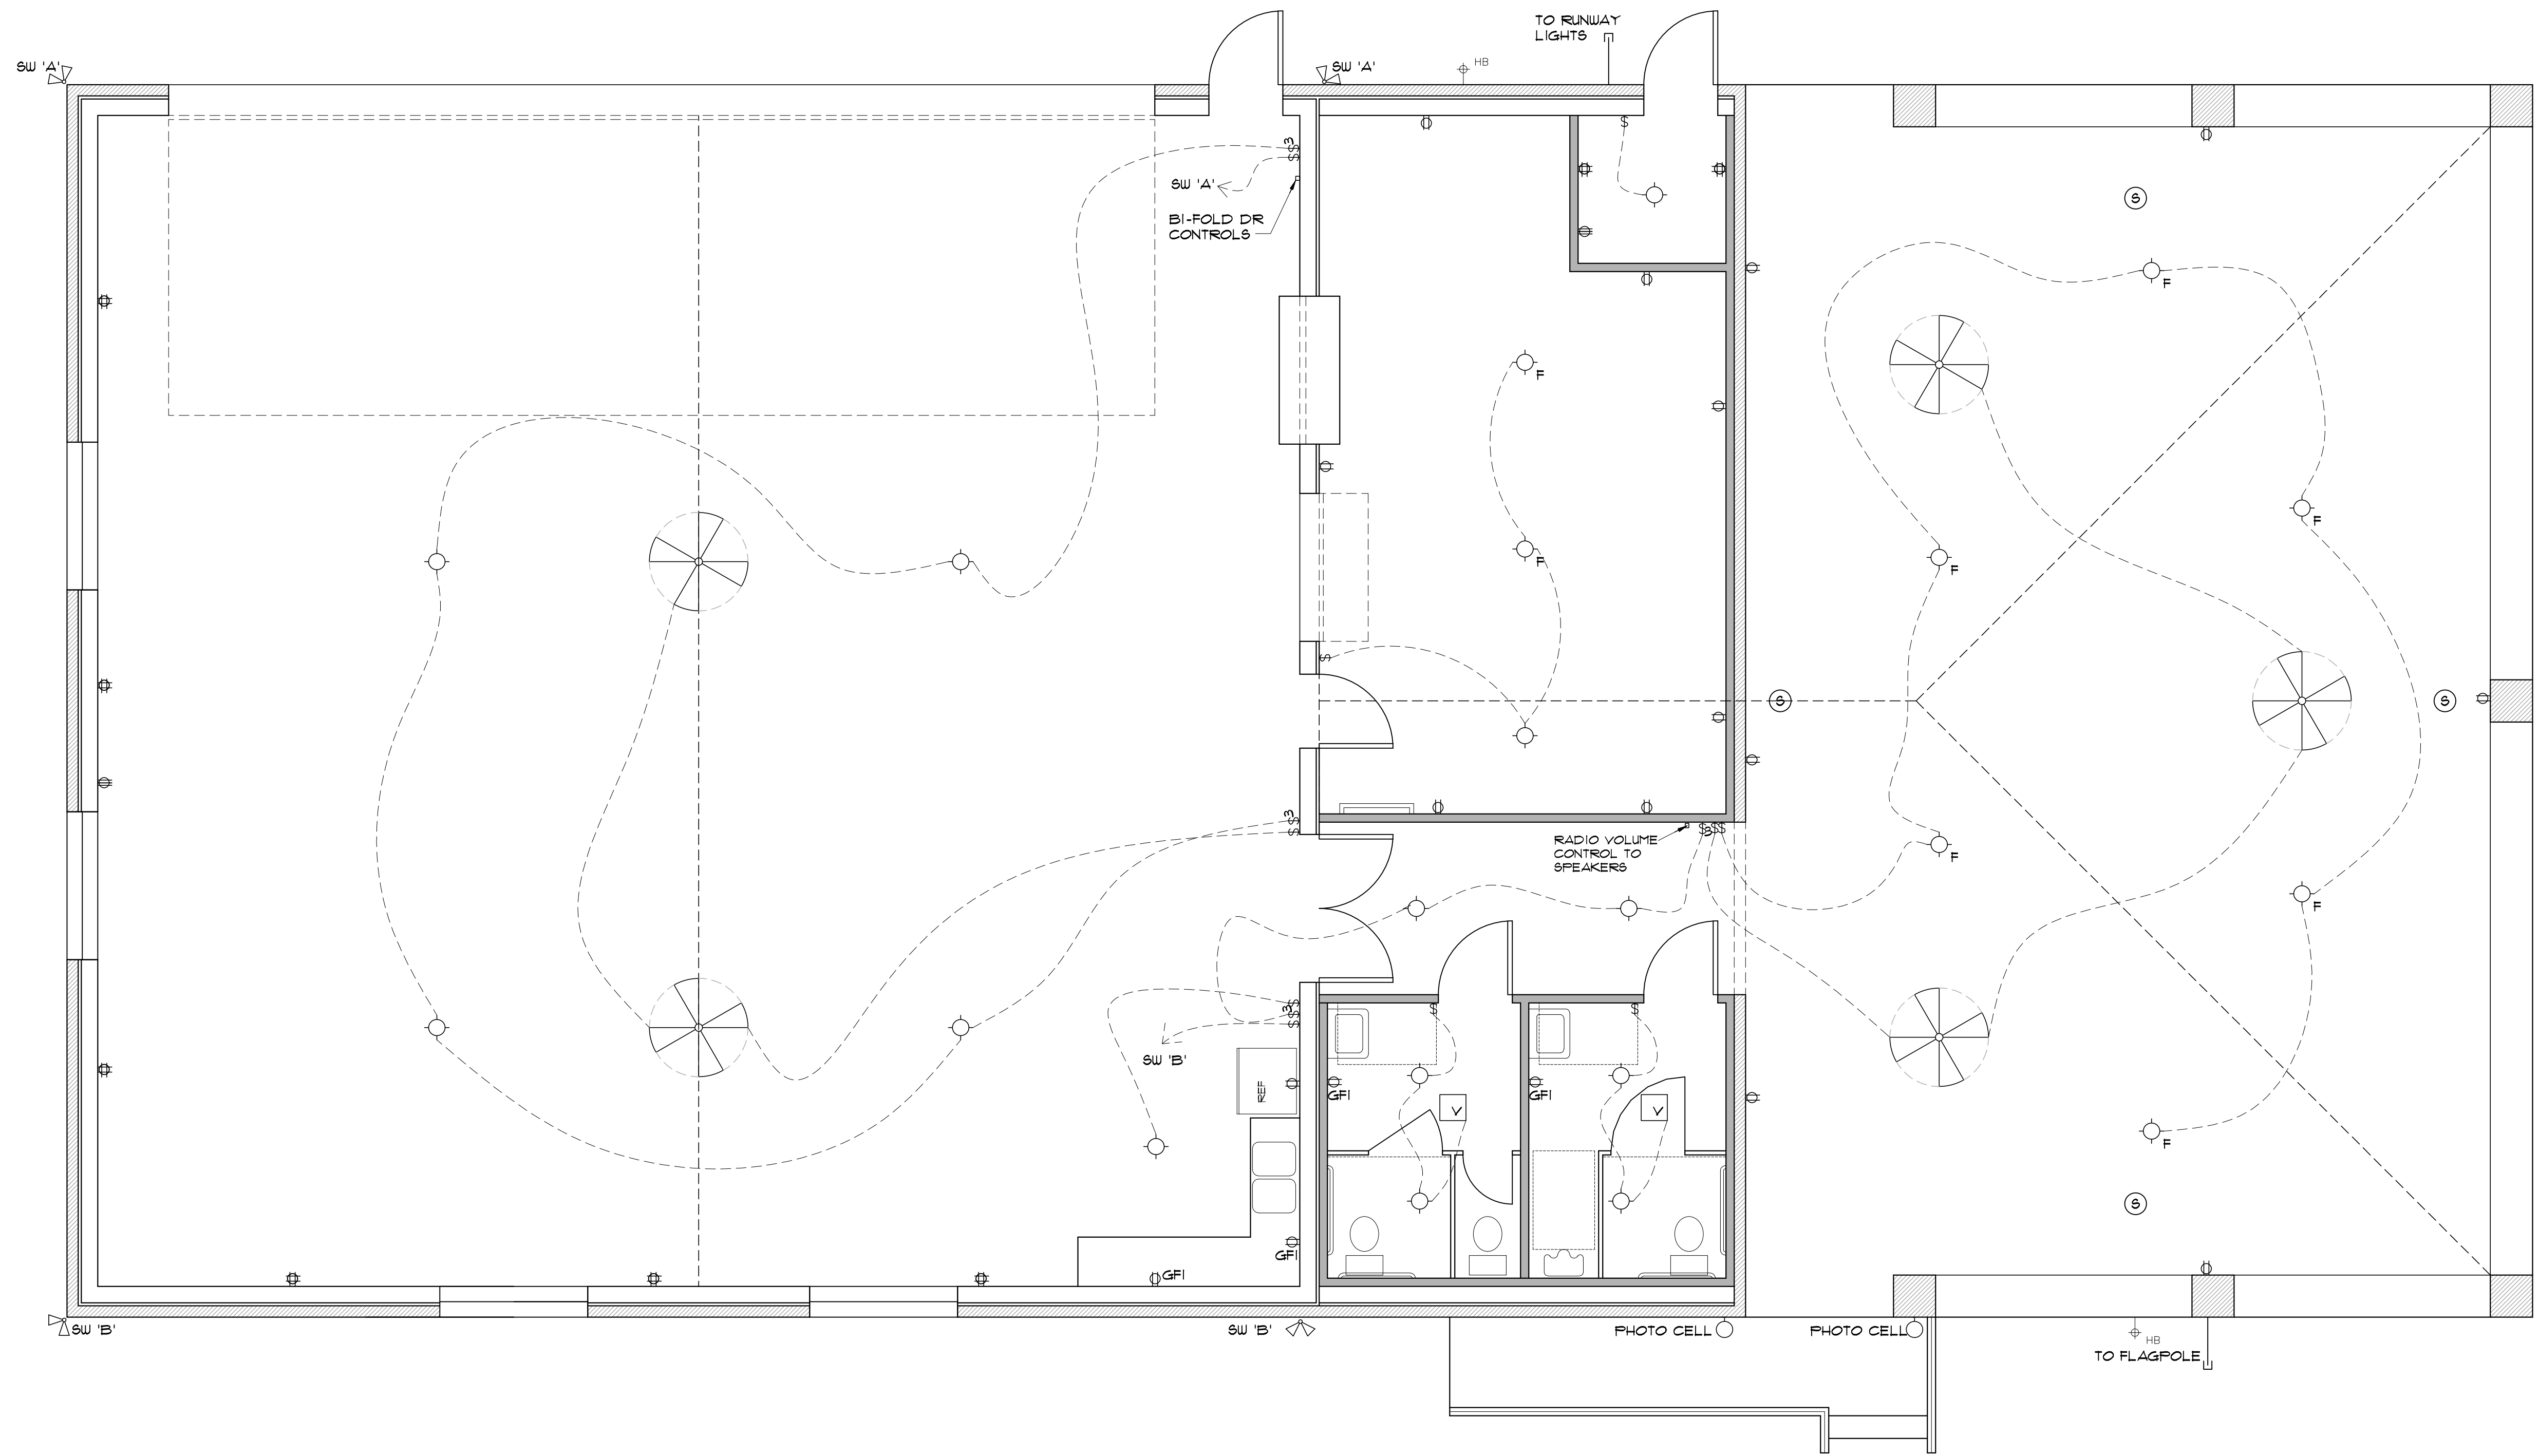

ELECTRICAL PLAN
 SCALE: 1/4" = 1'-0"



CONCEPTUAL SITE PLAN

SCALE

HOME DESIGNS
BY

MARCY

1891 Crawford Ave
Granbury, TX 76048
817-776-8024

These architectural drawings have been prepared for the use of the contractor and are not to be used for any other design or construction purposes. The architect is not responsible for the design or construction of any other related engineering design and specifications are the responsibility of the respective engineer. Compliance to these drawings shall be the responsibility of the contractor. Local building codes should be conformed to. All measurements shall be verified by the contractor performing the respective work.

**PLANEVIEW PARK
PECAN PLANTATION AIRPARK**

AREA CALCULATIONS

ENTERTAIN	3365 S.F.
OUTDOOR	1635 S.F.
TOTAL SLAB	5000 S.F.

	SHEET NO.
	SITE
DATE: 09/29/15	